



SYMBOL	RISK / HAZARD
	TREES HAVE PROTECTION ORDER IN PLACE. GUARDING REQUIRED. EXISTING TREES TO BE RETAINED.
	STEEP GRADIENTS TOPOGRAPHY OF THE SITE HAS A STEEP AVERAGE NATURAL GRADIENT.

KEY	
	SITE BOUNDARY
	PROPOSED SURFACE WATER DRAINAGE (TYPE B)
	PROPOSED SURFACE WATER INSPECTION CHAMBER 900x675 (TYPE D)
	PROPOSED SURFACE WATER INSPECTION CHAMBER 1240x675 (TYPE C)
	PROPOSED FOUL WATER DRAINAGE (TYPE B)
	PROPOSED FOUL WATER INSPECTION CHAMBER 1240x675 (TYPE C)
	EXISTING FOUL WATER SEWER & MANHOLE
	EXISTING SURFACE WATER SEWER & MANHOLE
	PROPOSED SURFACE WATER LATERAL
	PROPOSED FOUL WATER LATERAL
	PROPOSED PCC HEADWALL
	EXISTING PCC HEADWALL
	ROAD GULLY (150m ² CAPACITY)
	ROAD GULLY WITH PEDESTRIAN FRIENDLY GRATING (150m ² CAPACITY)
	PROPOSED SEWER EASEMENT

LATERALS AND PRIVATE DRAINAGE CONNECTIONS ARE NOT SHOWN.

ALL DRAINAGE WORKS TO BE OFFERED FOR ADOPTION SHALL COMPLY WITH THE REQUIREMENTS OF SEWERS FOR ADOPTION 6TH EDITION AND ARE SUBJECT TO APPROVAL OF SOUTHERN WATER.

- CDM NOTES:
- THE ATTENTION OF THE CLIENT AND THE PRINCIPAL CONTRACTOR IS DRAWN TO THE FOLLOWING POTENTIAL RISKS IN CONJUNCTION WITH THE PROPOSED ON-SITE AND OFF-SITE WORKS AS DESIGNED FOR THIS PROJECT:
 - WORKS IN THE VICINITY OF LIVE SERVICES WILL BE NECESSARY AND THE ADVICE OF ALL STATUTORY SERVICE COMPANIES MUST BE SOUGHT BEFORE ANY WORKS COMMENCE.
 - WORKS WITHIN AND ABUTTING THE EXISTING HIGHWAY WILL ENTAIL TRAFFIC HAZARDS AND ALL APPROPRIATE SAFETY MEASURES INCLUDING BARRIERS, SIGNS AND LIGHTING MUST BE UNDERTAKEN TO THE APPROVAL OF THE LOCAL AUTHORITY, THE HIGHWAY AUTHORITY AND THE POLICE.
 - HAZARDOUS MATERIALS INCLUDING CEMENT AND BITUMINOUS MATERIALS ARE SPECIFIED AND THE MANUFACTURER'S ADVICE ON SAFE HANDLING PROCEDURES MUST BE OBTAINED AND MADE CLEAR TO ALL OPERATIVES.
 - THE CONTRACTOR WILL BE RESPONSIBLE FOR LOCATING ALL EXISTING SERVICES WITHIN THE VICINITY OF THE WORKS AND ENSURE THESE ARE PROTECTED THROUGHOUT THE DURATION OF THE WORKS. ALL UTILITY PLANT SHOULD BE CLEARLY MARKED ON THE GROUND PRIOR TO COMMENCEMENT OF THE WORKS.
 - THE CONTRACTOR MUST ENSURE ALL WORKING AREAS ARE FULLY SECURE.

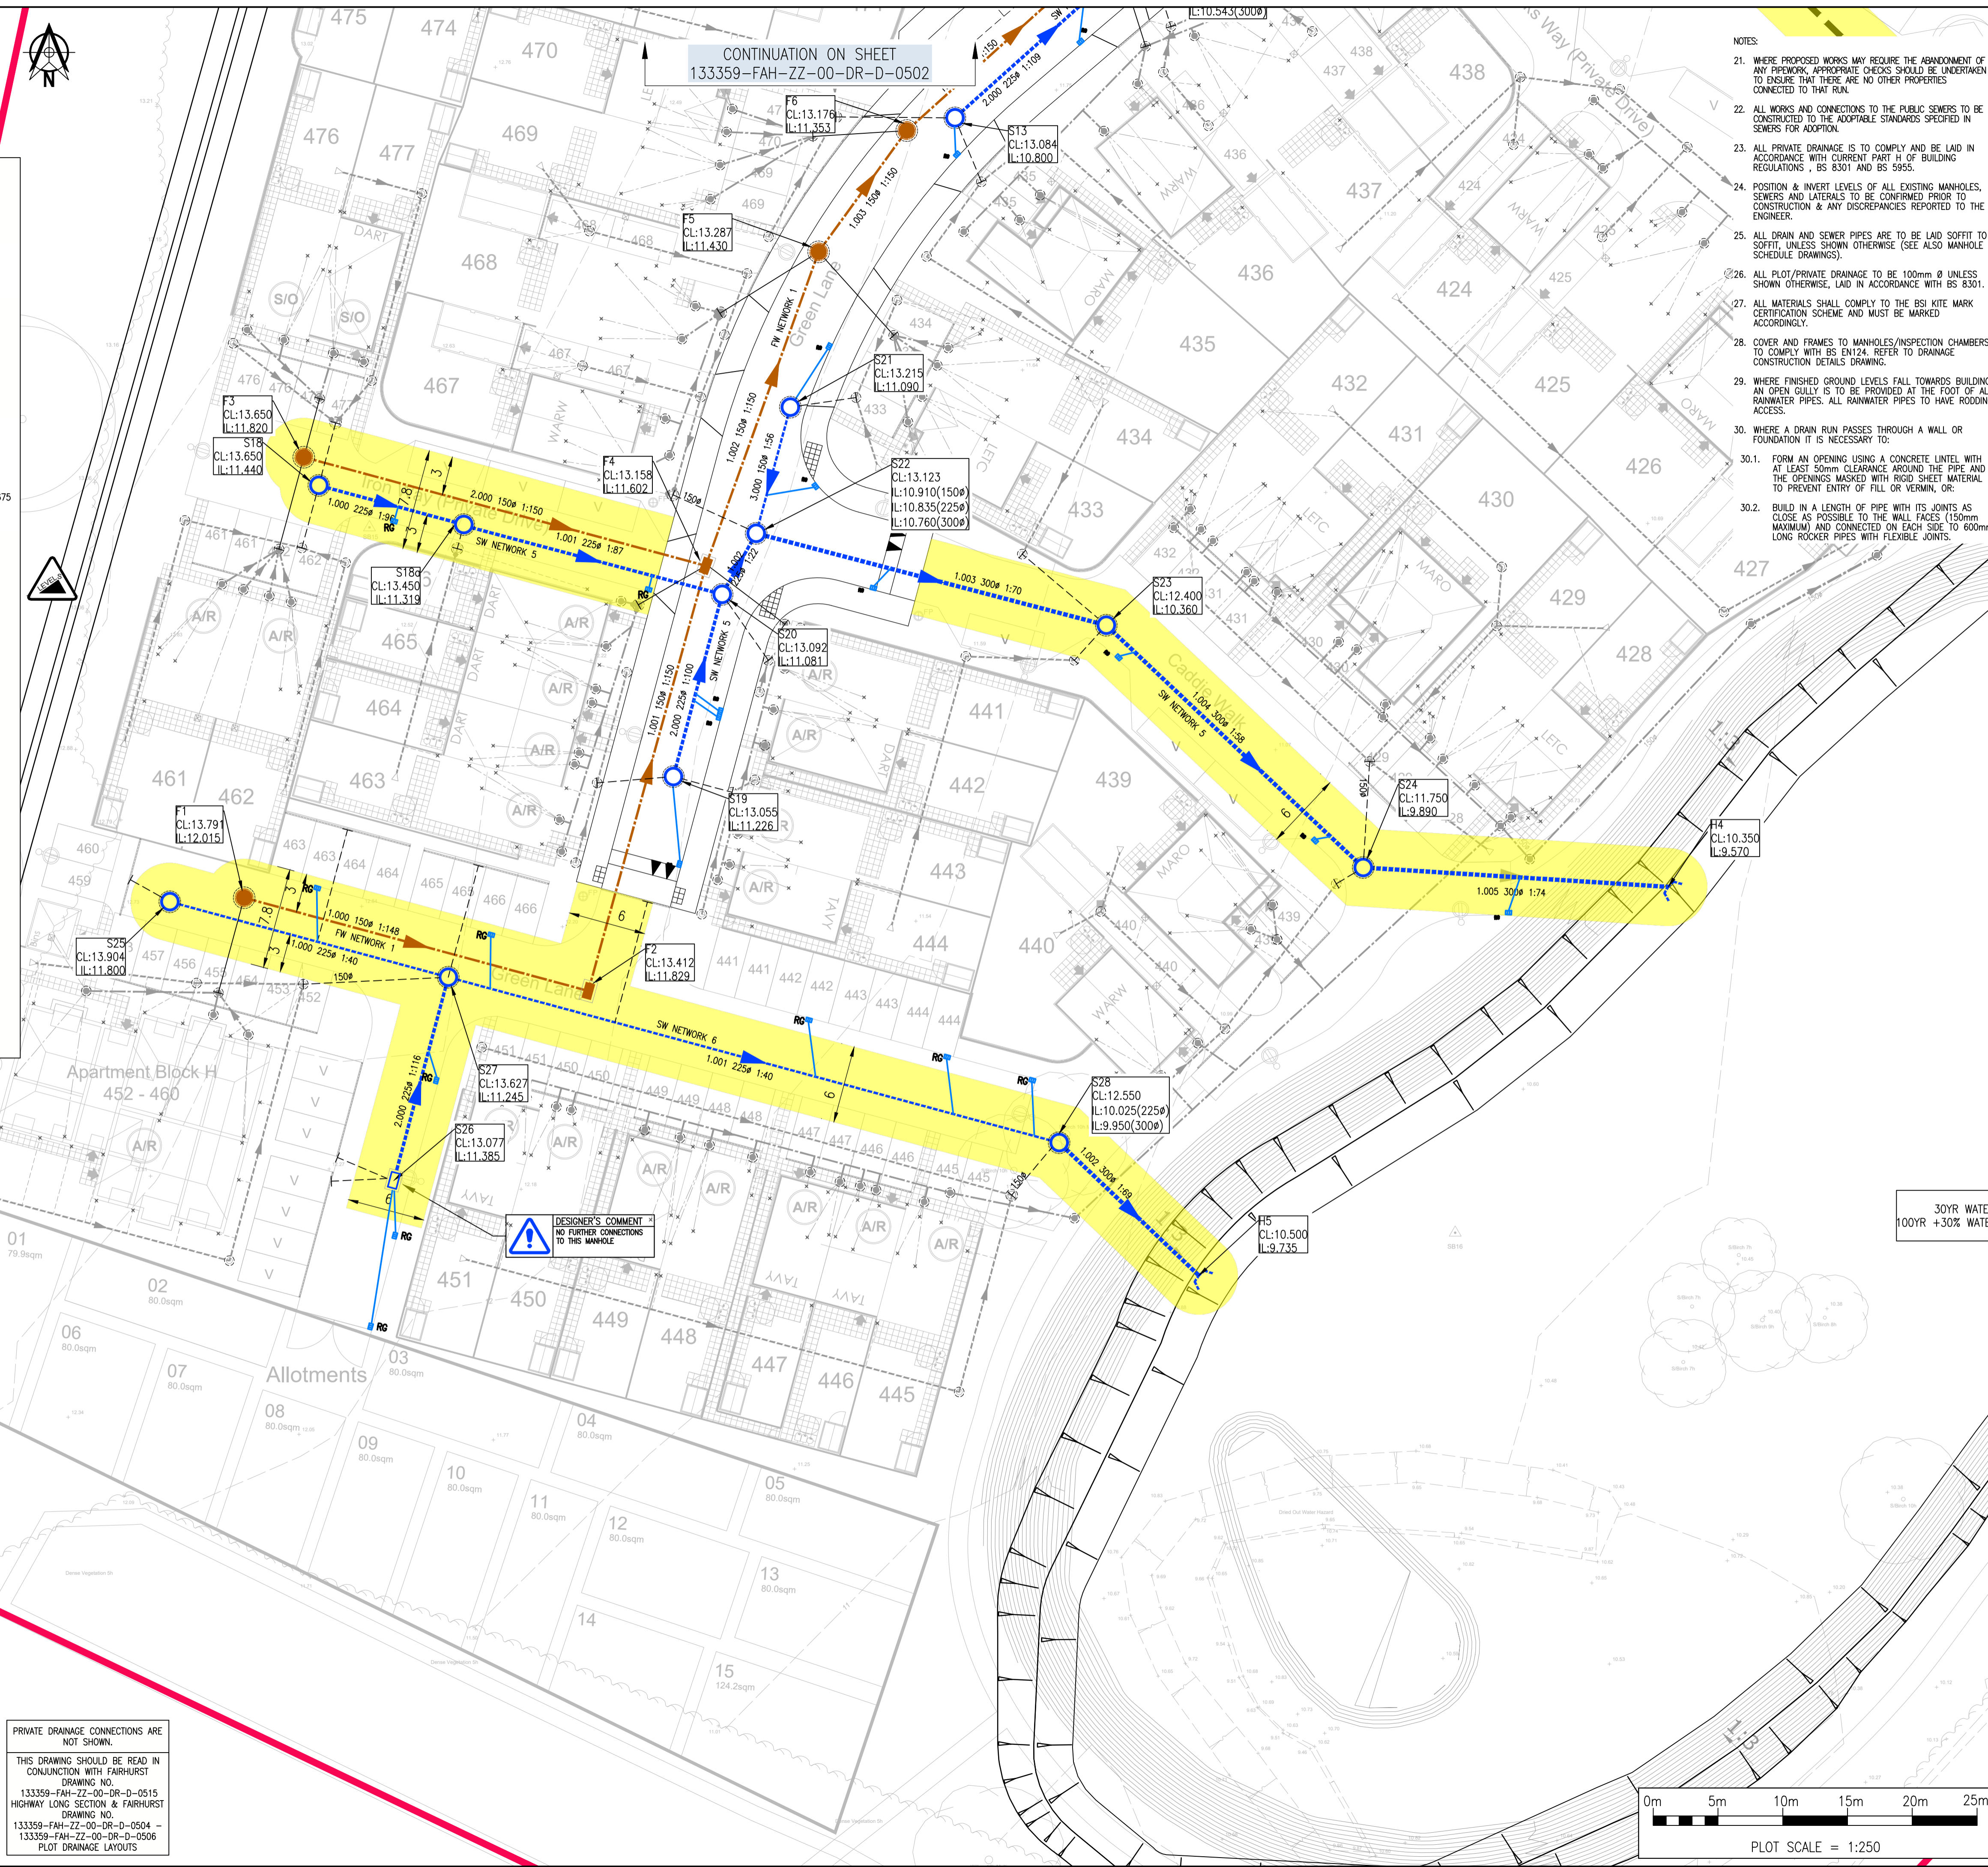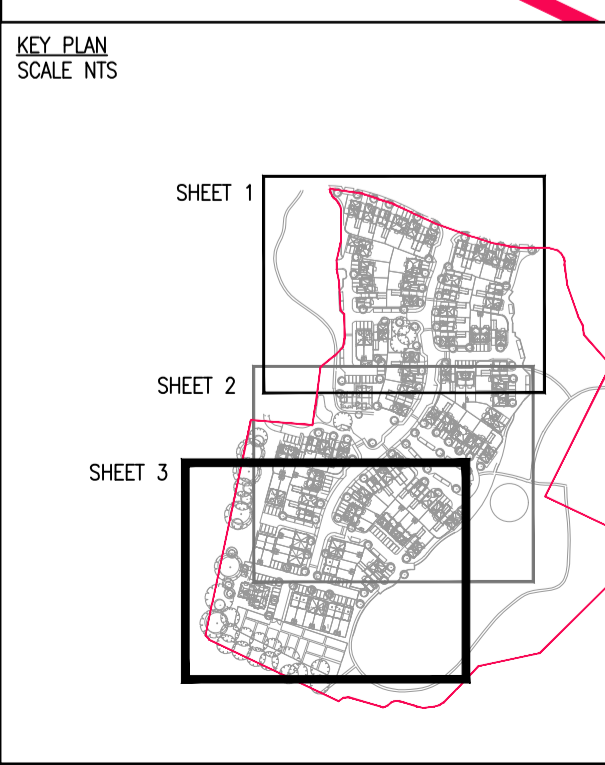

- DO NOT SCALE FROM THIS DRAWING
- NOTES:
- THIS DRAWING IS TO BE READ IN CONJUNCTION WITH THE RELEVANT SPECIFICATION, INRISK ASSESSMENTS (SEE CDM NOTES) AND ALL OTHER RELATED DRAWINGS ISSUED BY THE ENGINEER.
 - ALL DIMENSIONS SHOWN ON THIS DRAWING ARE IN METRES UNLESS OTHERWISE STATED.
 - ALL DIMENSIONS, LEVELS AND SURVEY GRID CO-ORDINATES ARE TO BE CHECKED ON SITE AND THE ENGINEER NOTIFIED IMMEDIATELY OF ANY DISCREPANCIES PRIOR TO THE COMMENCEMENT OF THE WORKS.
 - NO DEVIATION FROM THE DETAILS SHOWN ON THIS DRAWING IS PERMITTED WITHOUT PRIOR PERMISSION FROM THE ENGINEER.
 - ANY WORKS OUTSIDE SITE BOUNDARY ARE FOR INFORMATION PURPOSES ONLY. UNLESS SPECIFICALLY NOTED, ALL WORKS OUTSIDE THE SITE BOUNDARY WILL BE UNDERTAKEN BY OTHERS UNDER A SEPARATE CONTRACT.
 - THE CONTRACTOR SHALL UNDERTAKE SUCH MATERIALS TESTING AS INDICATED IN THE SPECIFICATIONS AND SHALL INCLUDE THE COST OF TESTING IN THE TENDER.
 - ALL EXISTING DRAINAGE TO BE RETAINED SHOULD BE SURVEYED AND REPAIRED IN ACCORDANCE WITH BS EN 1610 CONSTRUCTION AND TESTING OF DRAINS AND SEWERS.
 - STARTED COVER LEVELS ARE FOR GUIDANCE ONLY AND SHALL BE SET TO THE FINISH LEVELS OF THE CARRIAGEWAY/FOOTWAY/VERGE.
 - ALL PIPE SIZES STATED ARE NOMINAL INTERNAL DIAMETERS IN MILLIMETERS.
 - ALL DRAINAGE IS TO BE CONSTRUCTED IN ACCORDANCE WITH THE BUILDING REGULATIONS, BS EN 752 AND RELEVANT AGREEMENT CERTIFICATES.
 - DRAINS TO BE CONSTRUCTED USING FLEXIBLY JOINTED VITRIFIED CLAY PIPES TO BS 65 'SUPER STRENGTH' SPECIFICATION OR UPVC BUILDING DRAINAGE SYSTEM PIPEWORK TO BS EN 1401, BEDDED AND BACKFILLED IN ACCORDANCE WITH THE MANUFACTURER'S INSTRUCTIONS AND THE SPECIFICATIONS.
 - BACKFILLING OF DRAIN TRENCHES ADJACENT TO DWELLINGS OF OTHER STRUCTURES TO BE IN ACCORDANCE WITH THE BUILDING REGULATIONS PART 14, DIAGRAM 8.
 - ALL SOIL VENT PIPE, STUB STACKS, AIR ADMITTANCE VALVES AND RAIN WATER PIPE LOCATIONS ARE INDICATIVE ONLY. FOR ACTUAL LOCATIONS PLEASE REFER TO ARCHITECT'S PLANS AND ELEVATIONS.
 - GULLIES SITUATED IN AREAS ACCESSIBLE TO WHEELED VEHICLES WITHIN THE PRIVATE OR PARKING COURTYARDS TO BE OF SUITABLE CONSTRUCTION WITH IN SITU CONCRETE BED AND SURROUND, FITTED WITH DRAINAGE CASTINGS CODE TDS51 GRATING AND FRAME (OR SIMILAR APPROVED).
 - SURFACE WATER FROM PRIVATE AREAS IS NOT TO BE DISCHARGED ONTO THE PROPOSED HIGHWAY.
 - 2A TELESCOPIC (ELBOW) REST BEND IS TO BE PROVIDED AT THE BASE OF EACH FW STACK.
 - DRAINS IN AREAS OF MADE GROUND TO BE CONSTRUCTED BY FIRST MAKING UP THE AREA TO APPROXIMATELY FINISHED LEVEL AND THEN EXCAVATE THROUGH THE FILL MATERIAL INTO UNDISTURBED GROUND. THE DRAIN TRENCH IS THEN TO BE BACKFILLED TO FORMATION LEVEL USING SUITABLE GRANULAR FILL MATERIAL WELL COMPACTED IN LAYERS NOT EXCEEDING 225mm.
 - A SECTION 106/107 APPLICATION WILL BE REQUIRED PRIOR TO CONNECTION TO THE EXISTING SEWER.
 - ALL WORKS TO EXISTING SEWER WILL REQUIRE WRITTEN APPROVAL FROM THE STATUTORY UNDERTAKER PRIOR TO COMMENCEMENT OF WORKS.
 - ALL INTERNAL MANHOLES/CHAMBERS SHOULD BE FITTED WITH DOUBLE SEALED & LOCKABLE COVERS.

CONSTRUCTION			
C2	21.05.21	ROAD GULLIES MOVED FROM PLOT DRAINAGE LAYOUT TO MAIN DRAINAGE LAYOUT	KFM/RR/AC
C1	29.04.21	MINOR LEVEL AMENDMENTS AND UPDATES INLINE WITH CLIENT AND SOUTHERN WATER COMMENTS	CDU/RR/AC
T3	22.02.21	PLOTS 428-432 UPDATED SWALE 13 UPDATED	CDU/TH/AC
T2	22.01.20	UPDATED TO SOUTHERN WATER AND CLIENT COMMENTS	CDU/HJ/AC
T1	31.10.19	TENDER ISSUE	CDU/HJ/AC
P2	02.10.19	PRELIMINARY ISSUE	HJ/HJ/AC
P1	27.09.19	PRELIMINARY ISSUE	CDU/HJ/AC

Client:

FAIRHURST
135 Park Street,
LONDON
SE1 9EA

REDROW HOMES

Tel: 020 7828 8205
Fax: 084 4381 4412
Web: www.fairhurst.co.uk
Email: london@fairhurst.co.uk

Project Title:

HERNE BAY PHASE 3

Drawing Title:

**MAIN DRAINAGE LAYOUT
SHEET 3 OF 3**

Scale	FH Project Number	Purpose of issue	Status
1:250	133359	CONSTRUCTION	C

Drawn	Checked	Approved
CDU	HJ	AC

Drawn Date	Checked Date	Approved Date
18/09/19	18/09/19	18/09/19

Drawings Number:

133359-FAH-ZZ-00-DR-D-0503

Rev:

C2

