


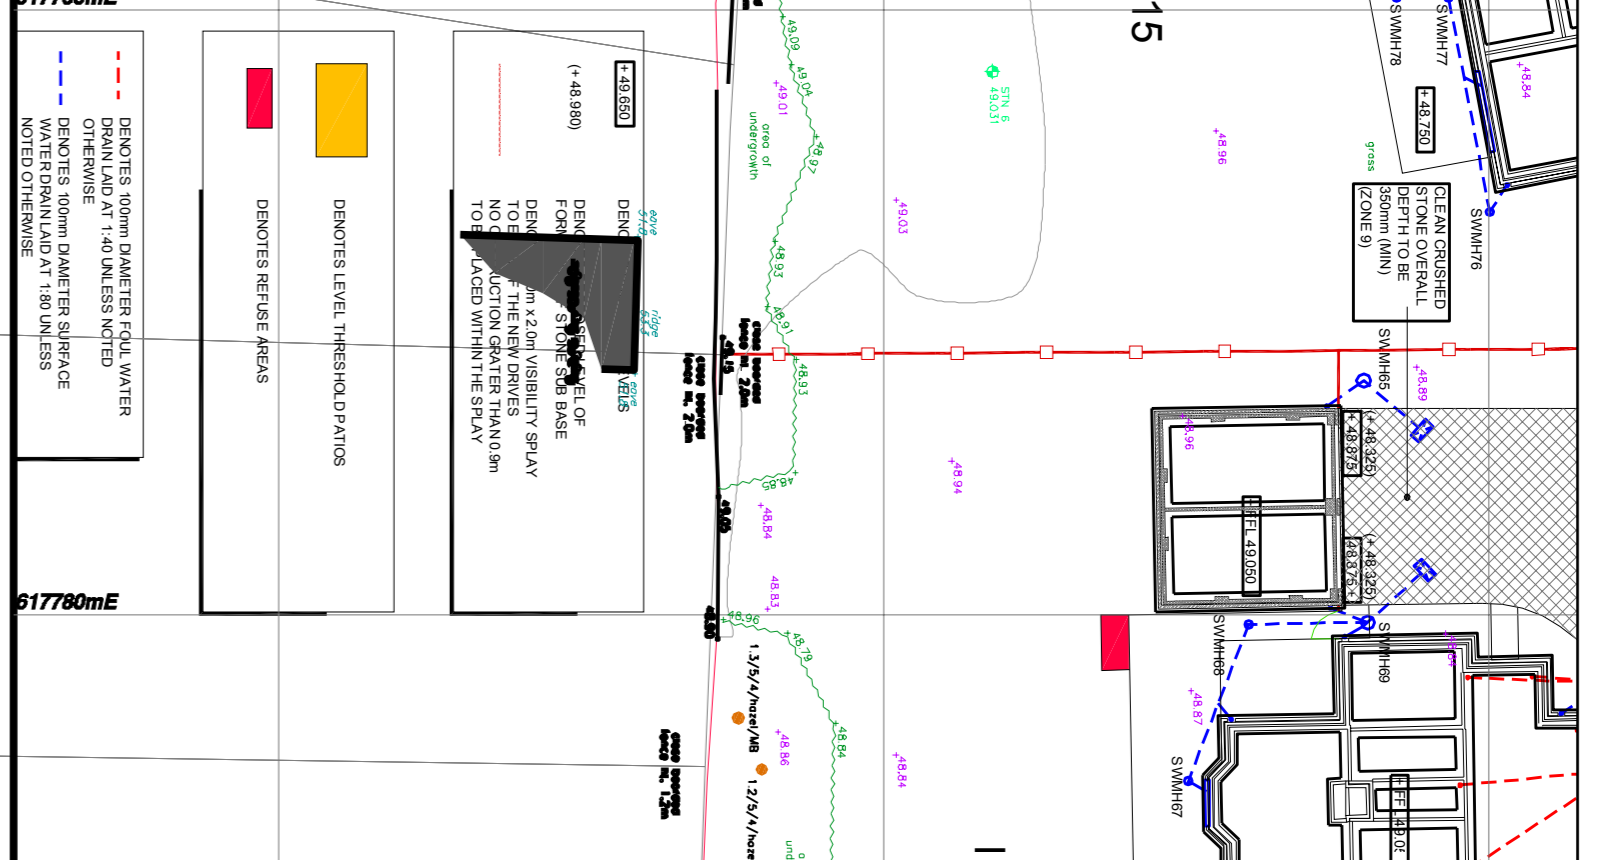


Armoriga
The Bury
New Haven
Hazeldene



Rev	Description	Date	By
P7	Layout updated to latest	26/09/17	gb
P6	Client layout. New survey	07/09/17	gb
P5	Client layout	15/04/15	gb
P4	Engineering notes updated.	02/04/15	er
P3	Layout updated. Drainage and paving added.	26/03/15	gb
P2	Layout updated.	26/02/15	gb
P1	First Issue	27/01/15	gb

Notes:

- This drawing is to be read in conjunction with all our other drawings, details & specification.
- This drawing is to be read in conjunction with the Architects drawings and all our drawings numbered 14037 inclusive.
- Do not scale from this drawing. This drawing is diagnostic only, so written dimensions should be taken in preference to scaled dimensions. The contractor is to take site dimensions for all items.
- All existing site levels are assumed to be approximate and are to be confirmed on site.
- All drainage pipes and fittings to be Male/female PVC-U or similar approved, 1000mm Ø, UNCO.

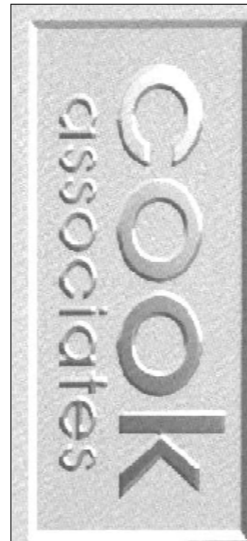

Architects
Engineers
Surveyors
Interior Designers
Capital House, 3 Jubilee Way,
Faversham, Kent ME13 8GD
Tel: 01795-532834 / 531022
e-mail: mail@cook-design.com
Fax: 01795-535605
Website: www.cook-design.com

Client:
Millwood Designer Homes Limited
Project:
Polo Farm Sports Club
Littlebourne Road
Canterbury CT3 4AF

Project No:
14037
Drawing Title:
Highway Layout
and Drainage Layout
Sheet 1 of 2

Drawn by:	APJ/M	Checked by:	GB
Date:	January 2015	Scale @:	AS1
PRELIMINARY			
Drawing No:	600	Rev. No.:	P7